



 



**Legend**

-  Emergency Exit
-  Severe Weather Area
-  Fire Extinguisher
-  Emergency Phone






**1** ANN STUART SCIENCE BUILDING  
 1ST FLOOR PLAN  
 SCALE: 1/32" = 1'-0"

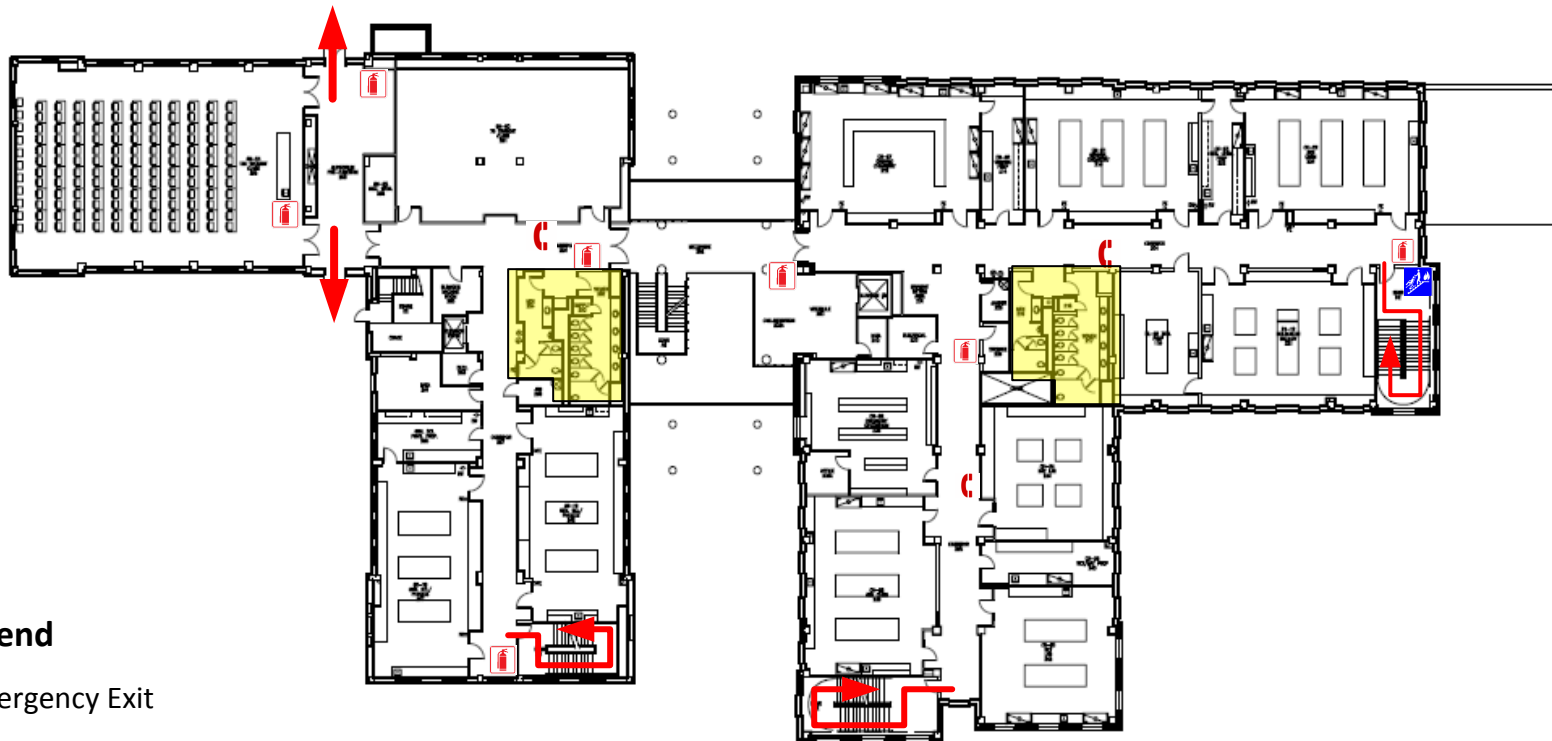


LEGEND	
FIRE PULL	FIRE
FIRE EXTINGUISHER	F.E.O.
FIRE EXIT IN CABINET	F.E.O.I.
EYEWASH STATION	EW-O




**Legend**

 -  Emergency Exit
-  Severe Weather Area
-  Fire Extinguisher
-  Emergency Phone
-  Evacuation Chair


1 ANN STUART SCIENCE BUILDING  
 2ND FLOOR PLAN SCALE: 1/32" = 1'-0"





LEGEND	
FIRE PULL	FIRE
FIRE EXTINGUISHER	TELE
FIRE EXIT IN CABINET	FEELS
EVACUATION CHAIR	EW-C

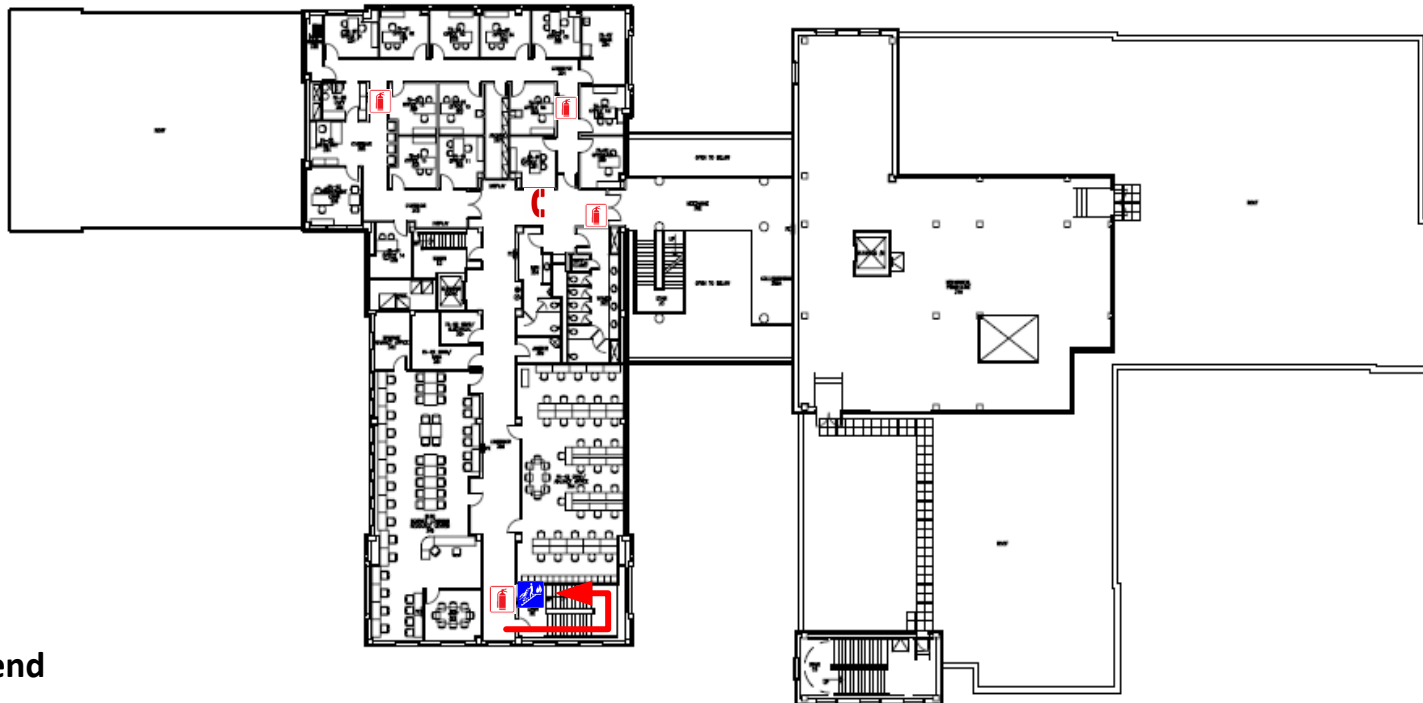

**Legend**

 -  Emergency Exit
-  Fire Extinguisher
-  Emergency Phone
-  Evacuation Chair




LEGEND	
FIRE PULL	FIRE-
FIRE EXTINGUISHER	FEQ
FIRE EXT IN CABINET	FECS
EXTINGUISHER STATION	EWQ