 





Legend

 
- Emergency Exit
- Severe Weather Area
- Fire Extinguisher
- Emergency Phone



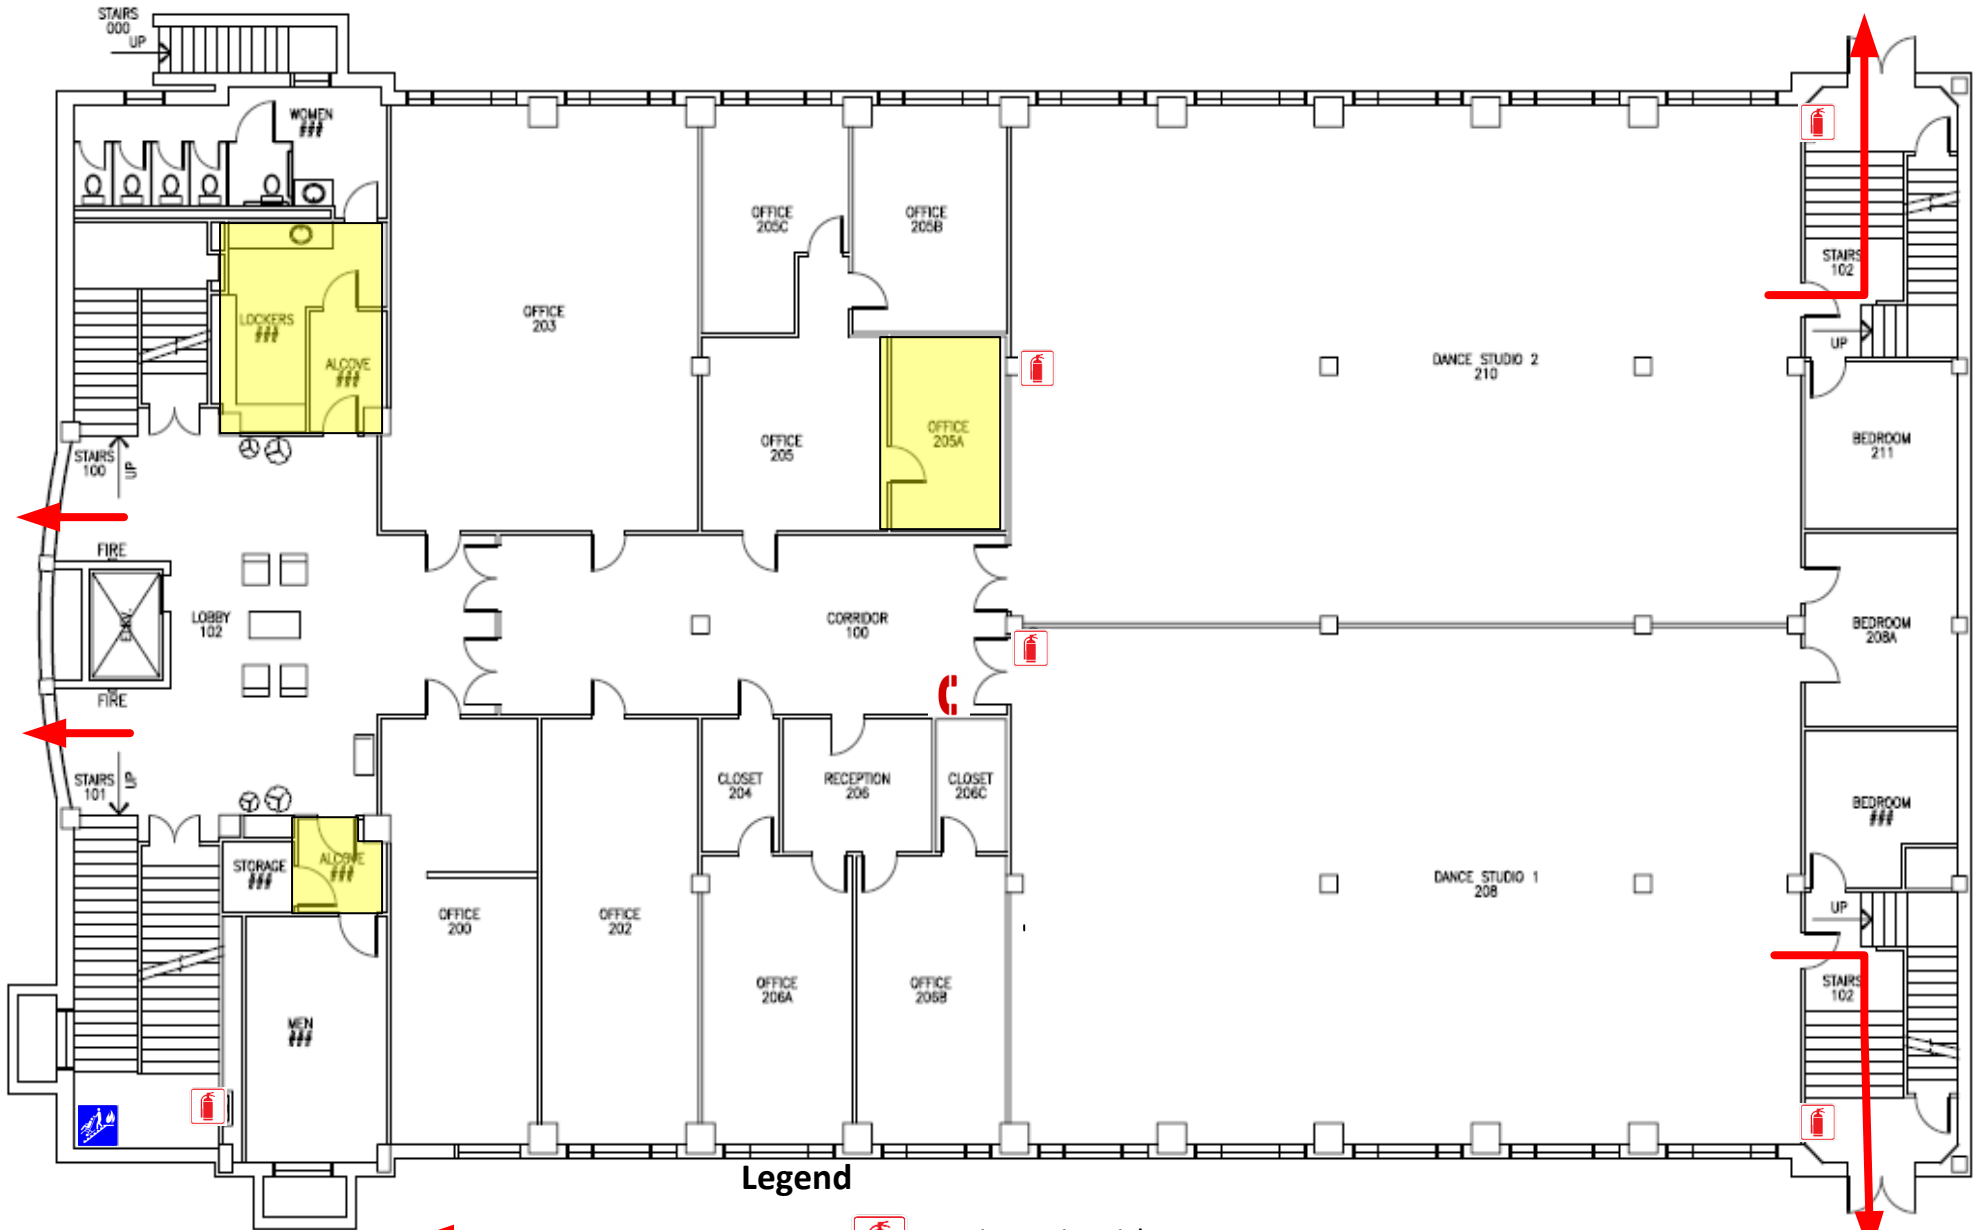


Legend

- Emergency Exit
- Severe Weather Area
- Fire Extinguisher
- Emergency Phone
- Evacuation Chair



1 DANCE GYM LAB BUILDING
1ST FLOOR PLAN SCALE: 3/32" = 1'-0"

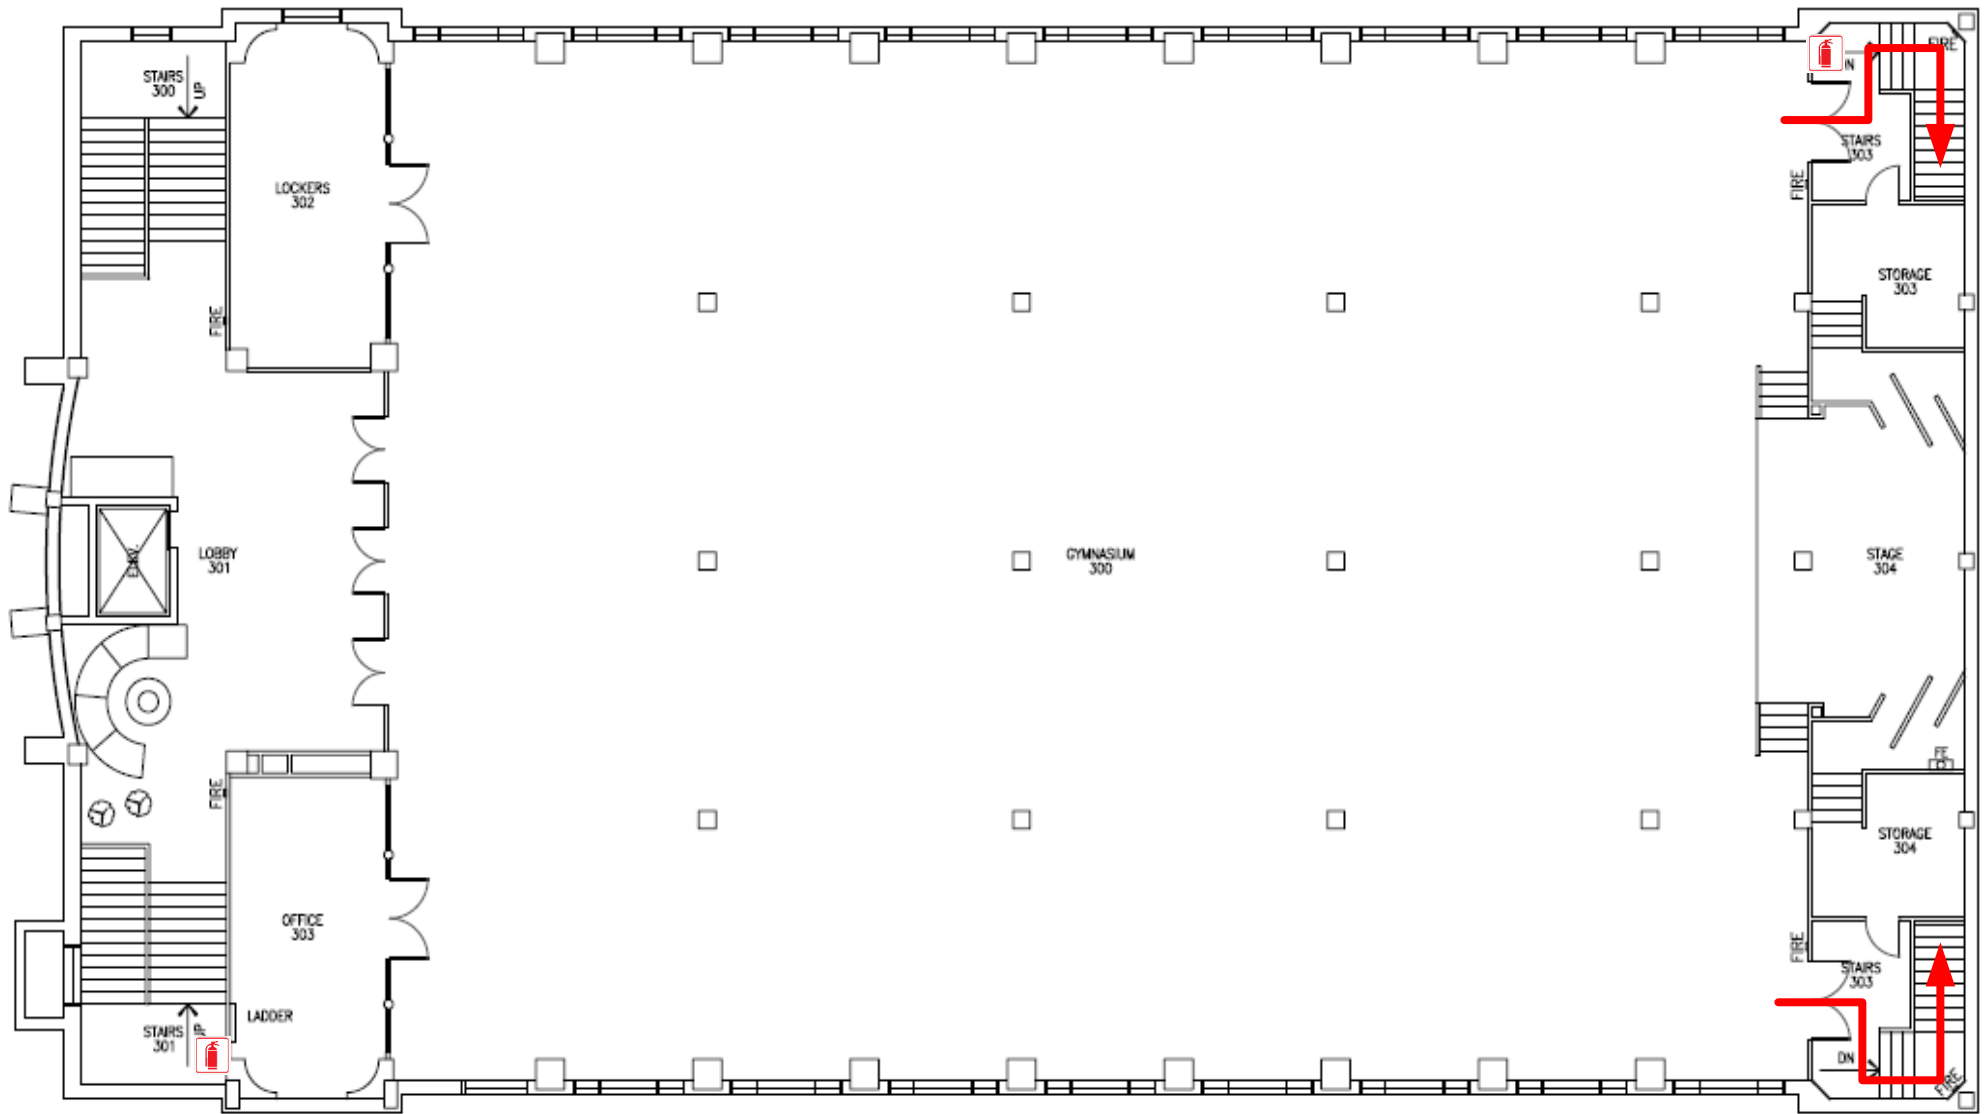

Legend

- 
Emergency Exit
- 
Fire Extinguisher

GRAPHIC SCALE

