



 


Legend


-  Emergency Exit
-  Severe Weather Area
-  Fire Extinguisher
-  Emergency Phone

1 OLD MAIN BUILDING
1ST FLOOR PLAN





SCALE: 1/16" = 1'-0"

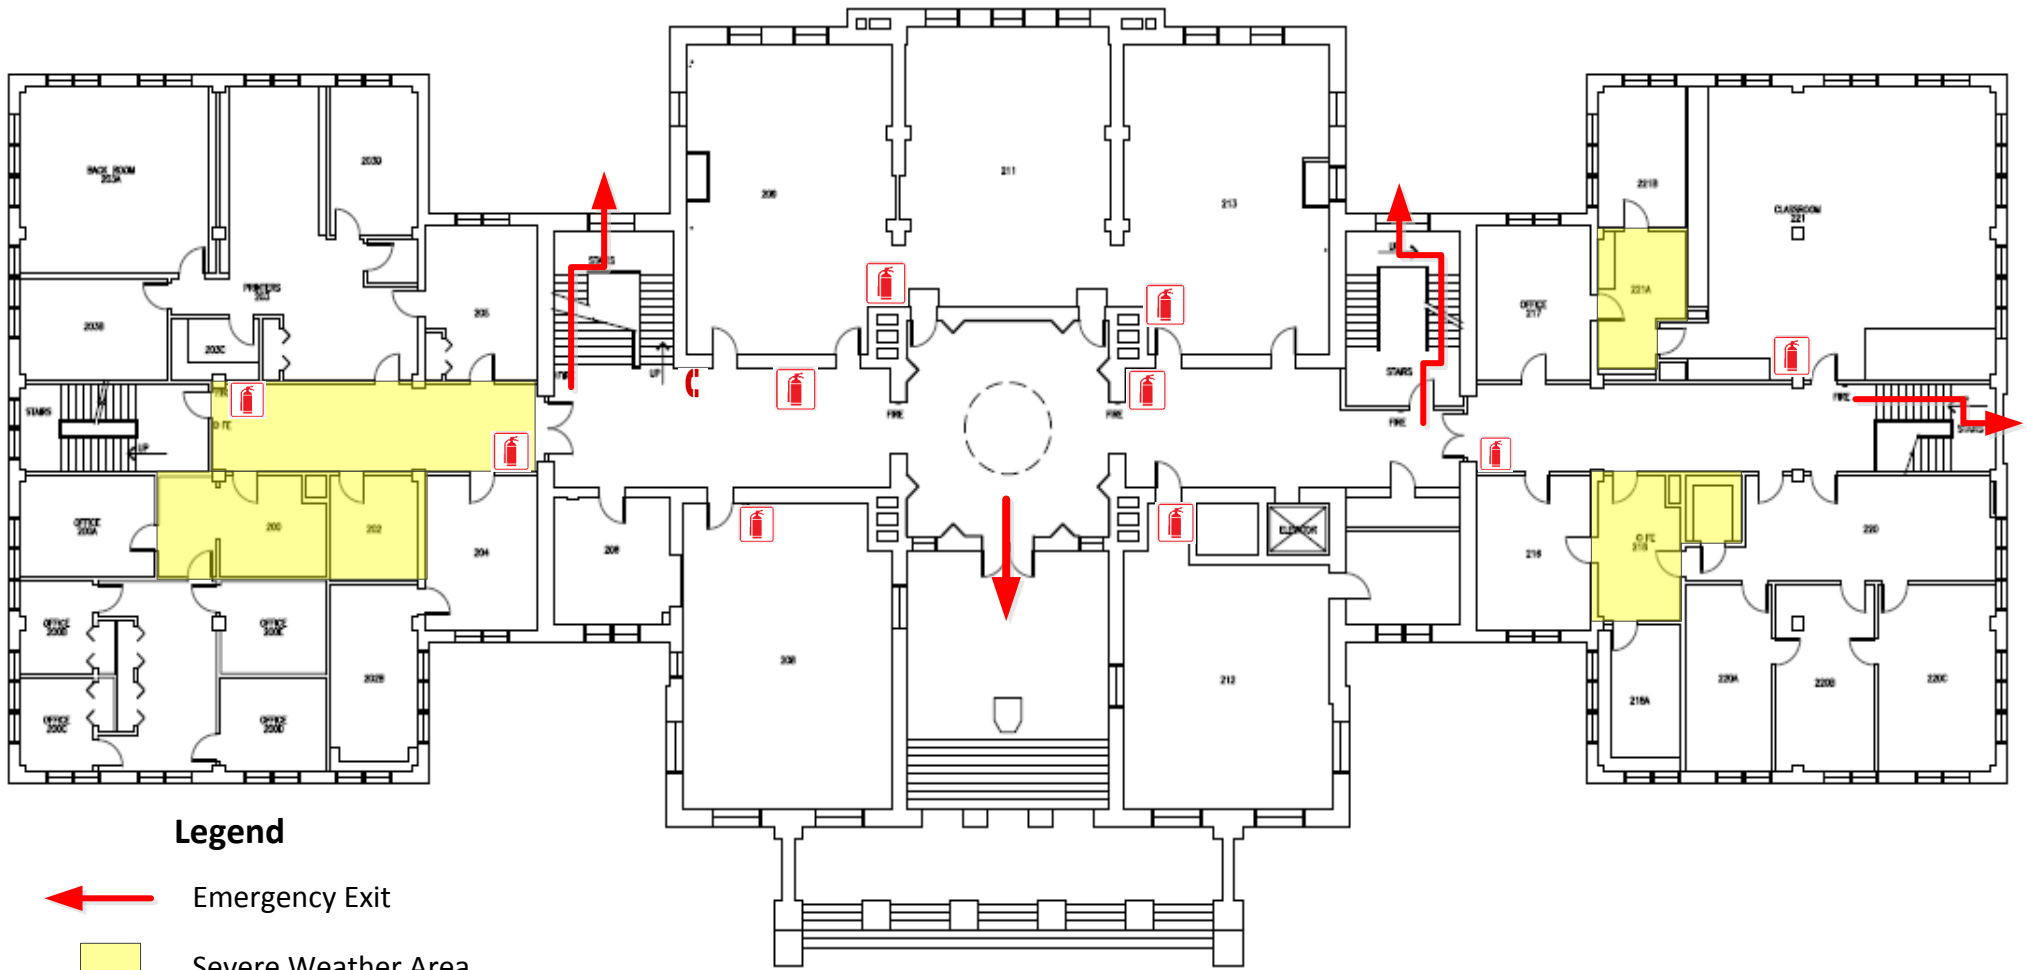

 
LEGEND
FIRE PULL FIRE-
FIRE EXTINGUISHER FE




Legend





-  Emergency Exit
-  Severe Weather Area
-  Fire Extinguisher
-  Emergency Phone

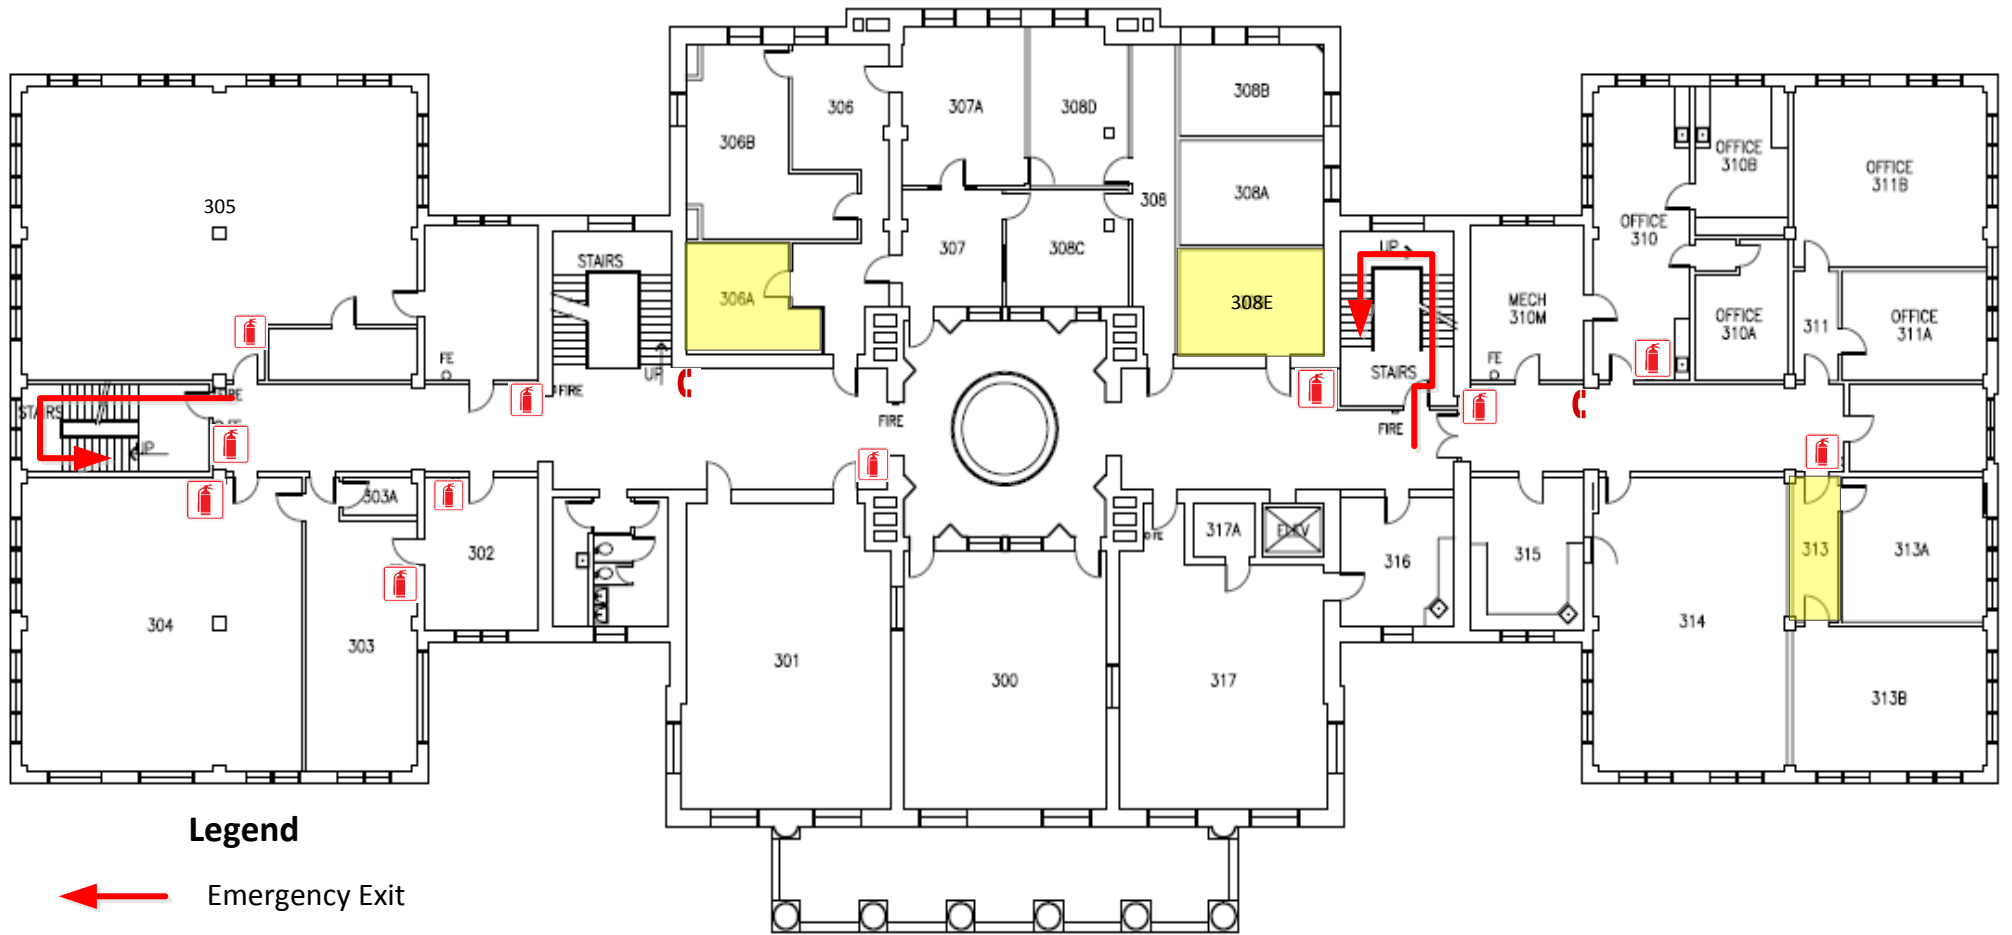1 OLD MAIN BUILDING
 2ND FLOOR PLAN
 SCALE: 1/16" = 1'-0"

 





Legend

-  Emergency Exit
-  Severe Weather Area
-  Fire Extinguisher
-  Emergency Phone




1 OLD MAIN BUILDING
 3RD FLOOR PLAN
 SCALE: 1/16" = 1'-0"

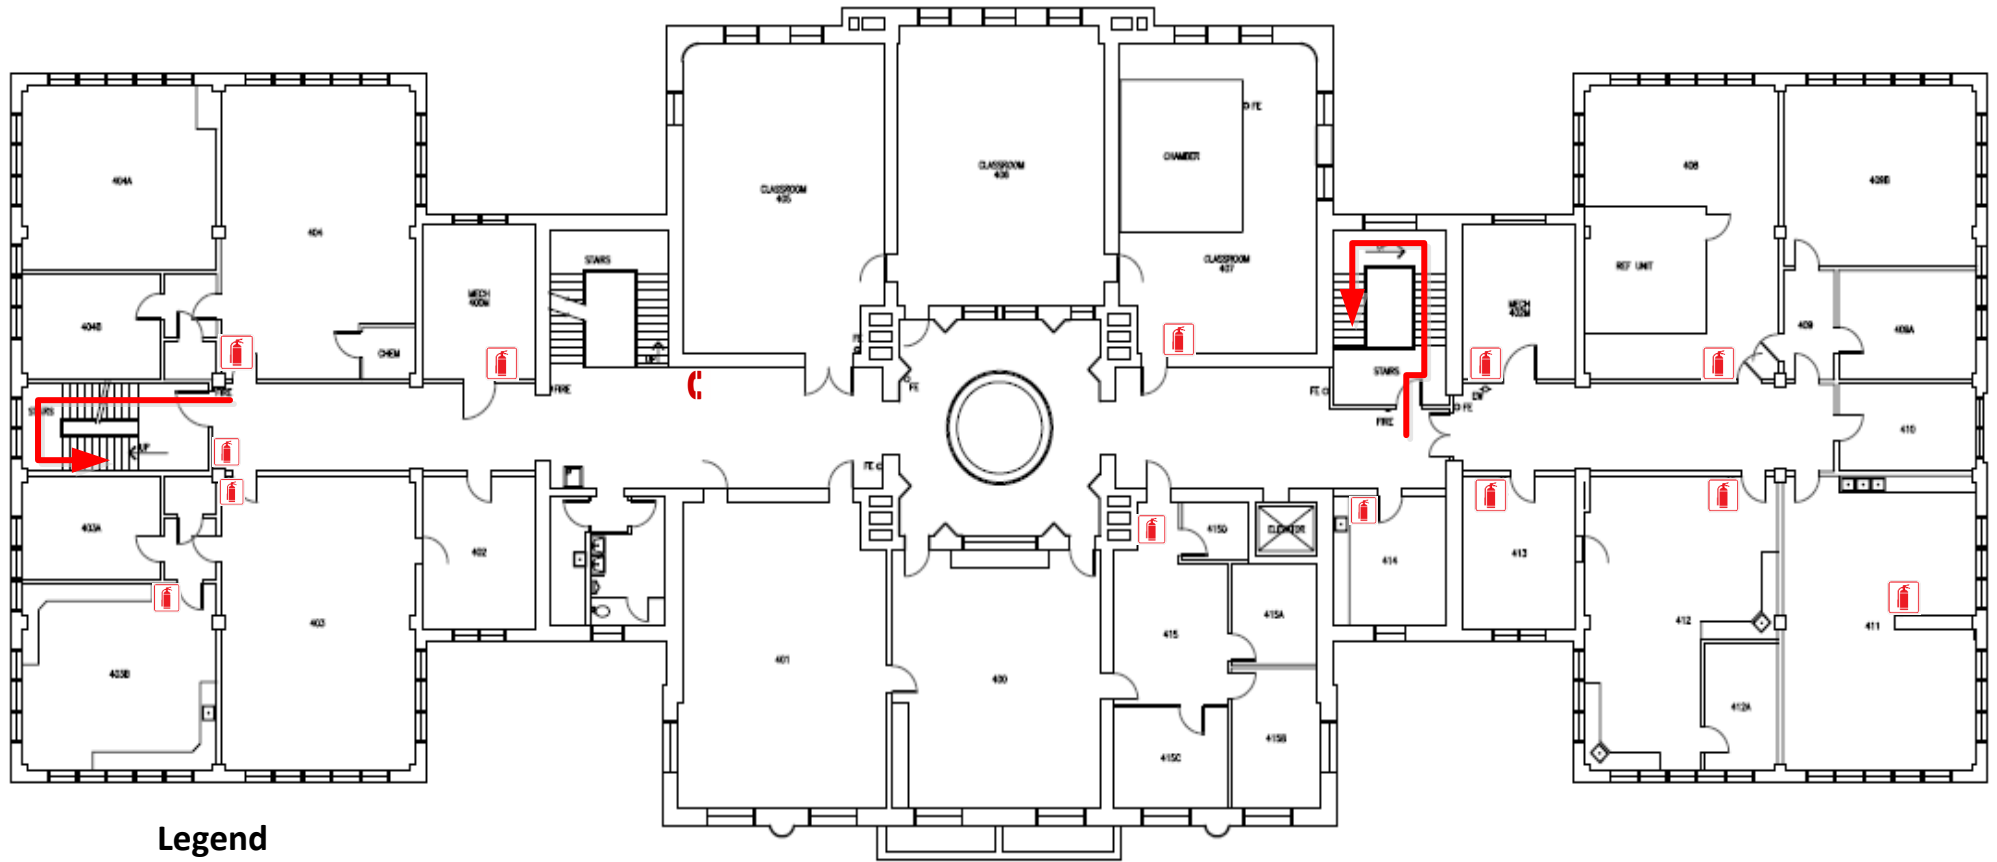

LEGEND
 FIRE PILL FIRE-
 FIRE EXTINGUISHER FE O



Legend

-  Emergency Exit
-  Fire Extinguisher
-  Emergency Phone



1 OLD MAIN BUILDING
4TH FLOOR PLAN

SCALE: 1/16" = 1'-0"

