 



Legend

-  Emergency Exit
-  Severe Weather Area
-  Fire Extinguisher
-  Emergency Phone
-  Automated External Defibrillator

 
1 PIONEER HALL BUILDING
1ST FLOOR PLAN
SCALE: 1/32" = 1'-0"



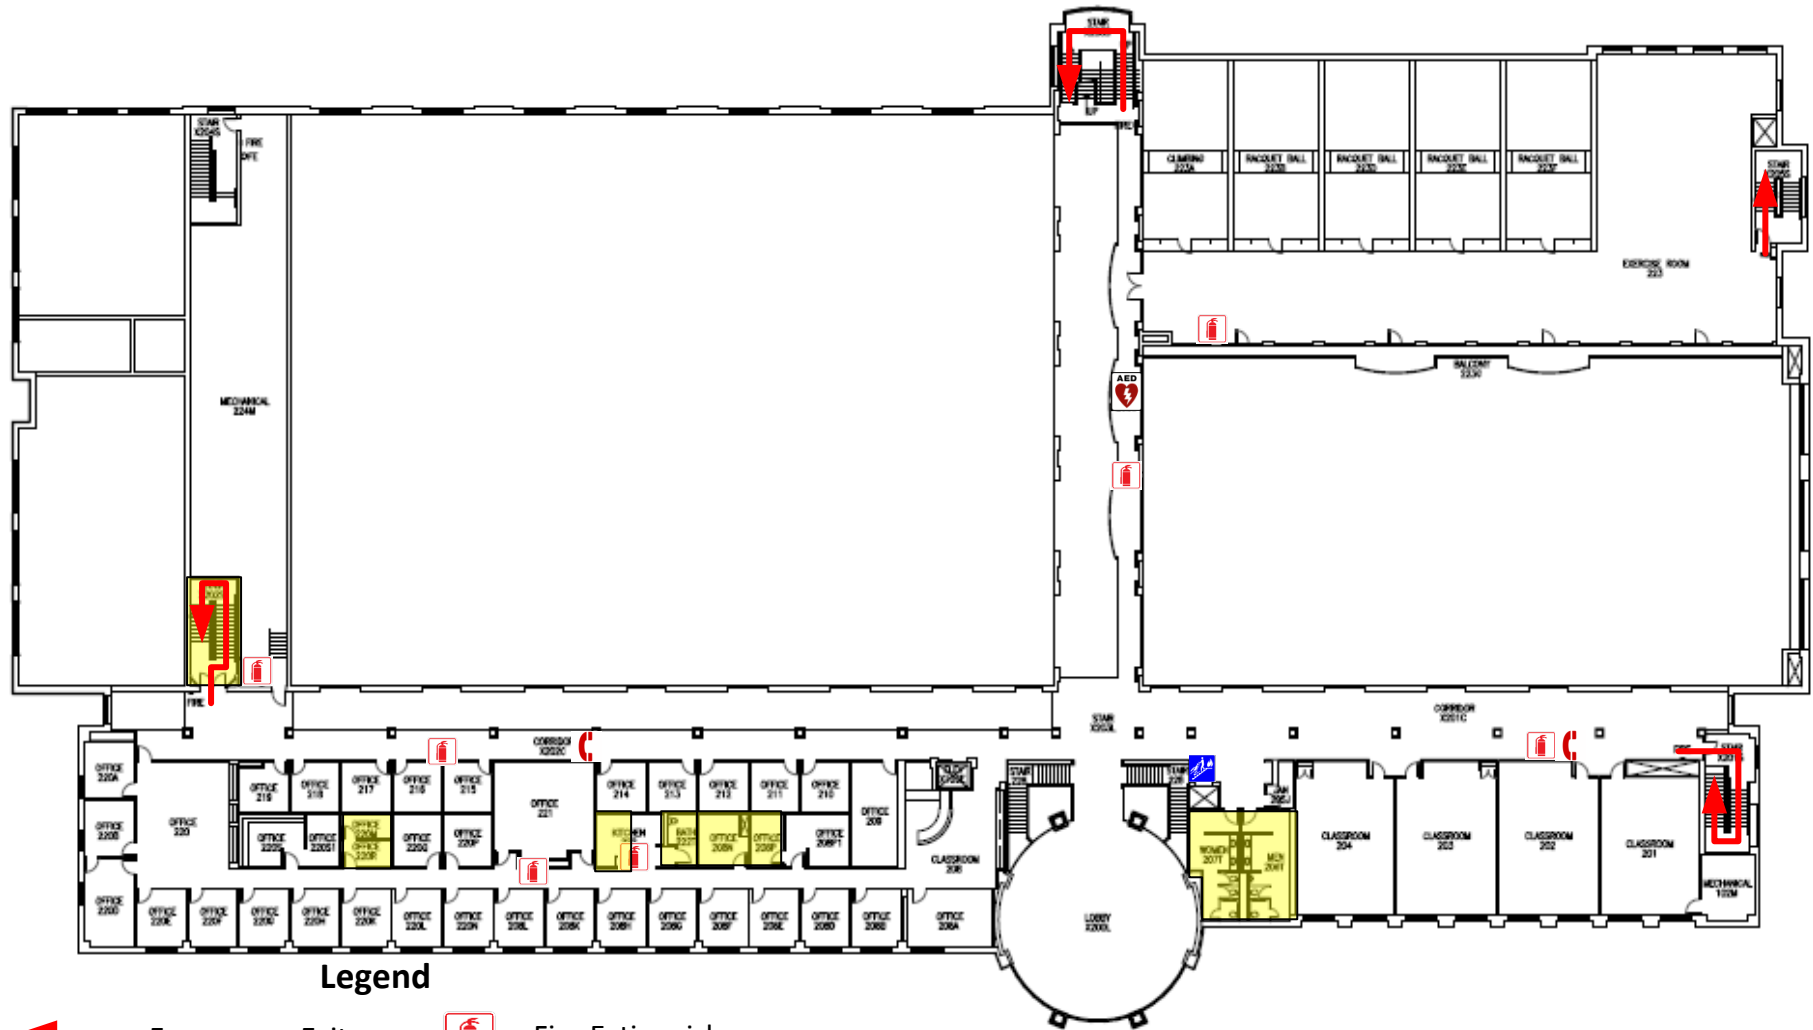


Legend




-  Emergency Exit
-  Fire Extinguisher
-  Severe Weather Area
-  Emergency Phone
-  Evacuation Chair
-  Automated External Defibrillator

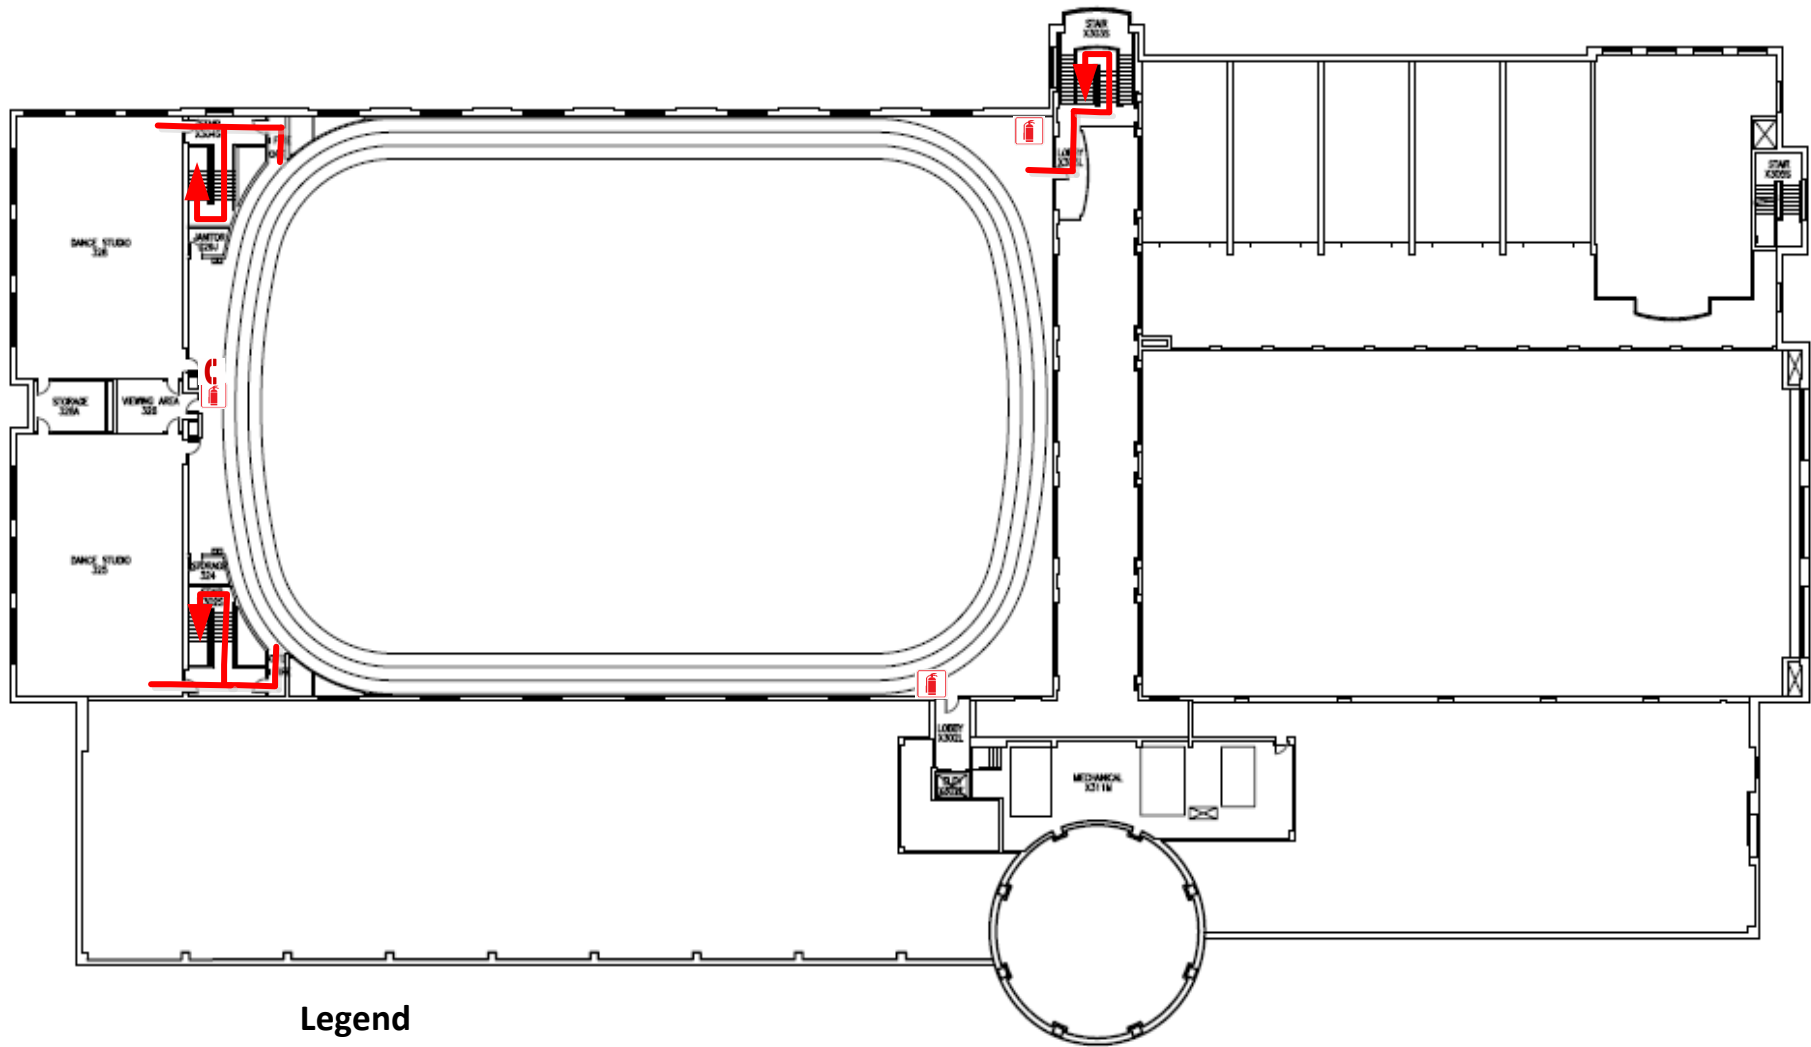

LEGEND
FIRE PAIL FIRE EXTINGUISHER F.E.D.



Legend

-  Emergency Exit
-  Fire Extinguisher
-  Emergency Phone

1 PIONEER HALL BUILDING
3RD FLOOR PLAN

SCALE: 1/32" = 1'-0"

